


V-101
FREE WATER KNOCK-OUT
SIZE: 3048 O.D. X 12192 S/S
DESIGN PRESSURE: 517 kPaG
DESIGN TEMPERATURE: 50° C
CORROSION ALLOWANCE: 1.6 MM

H-101
FIRE TUBE
SIZE: 610 O.D. X 7005 O/A
DESIGN PRESSURE: 517 kPaG EXTERNAL
DESIGN TEMPERATURE: 343° C.
CORROSION ALLOWANCE: 3 MM

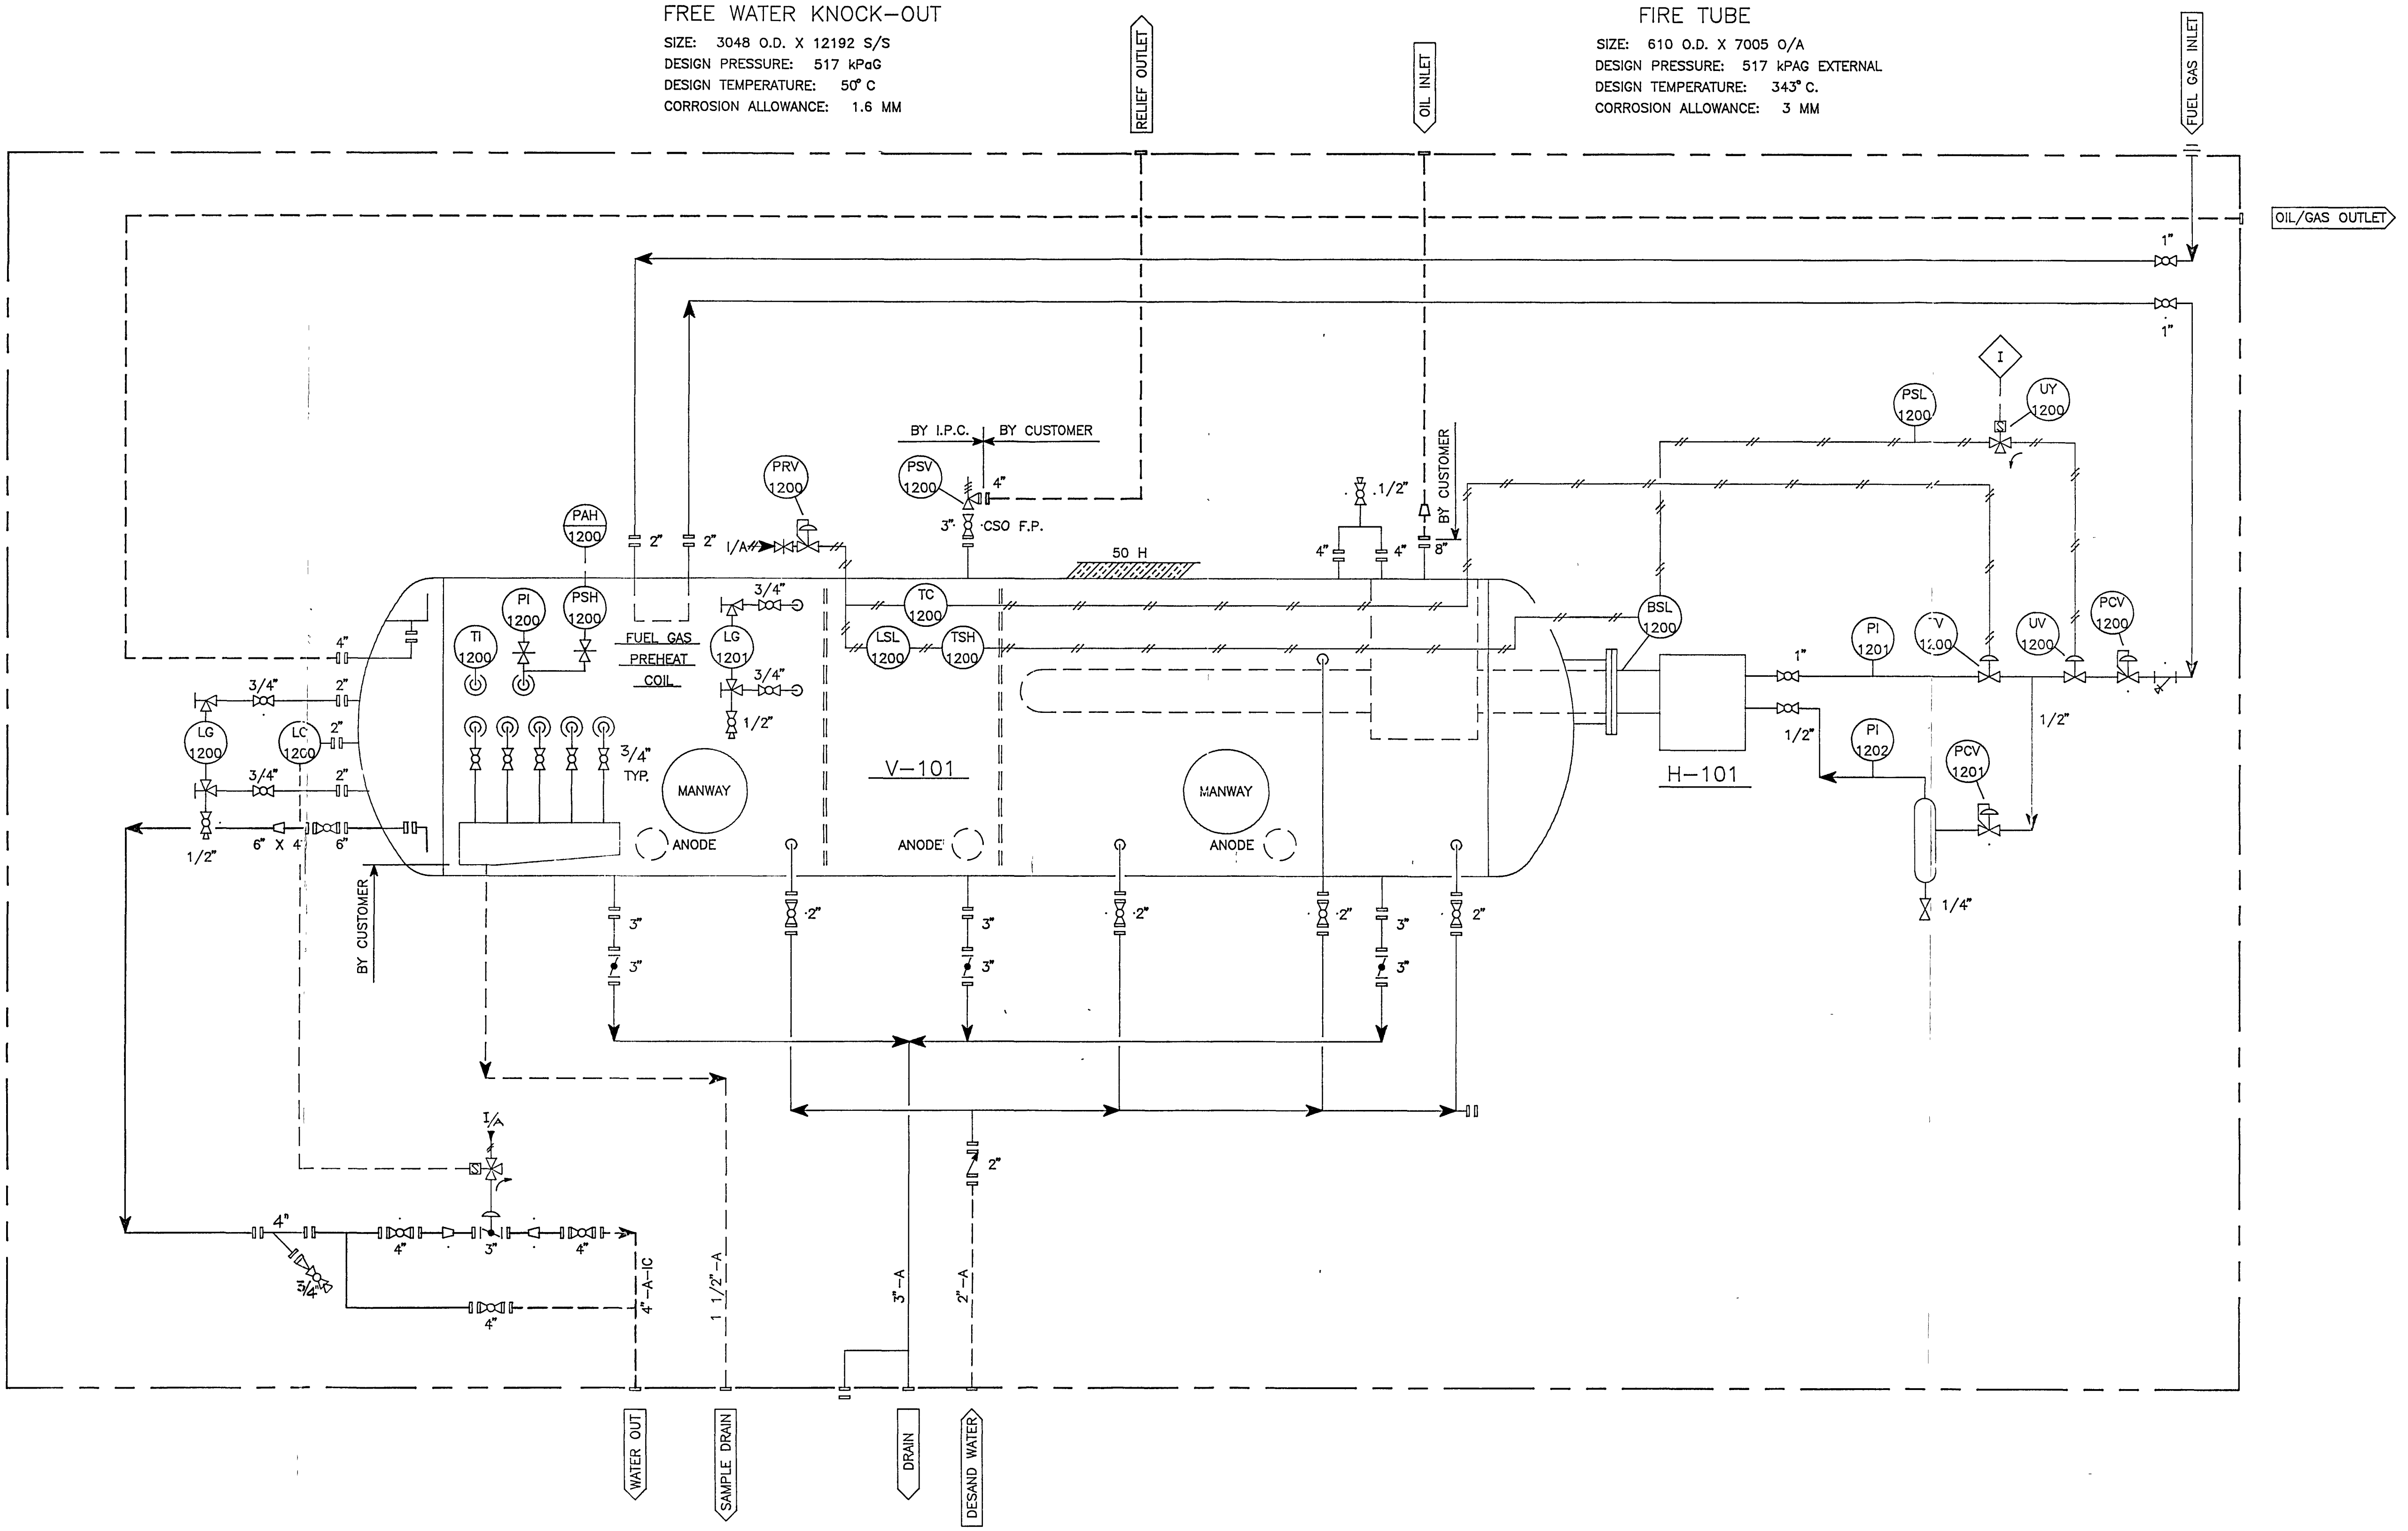

NOTES:					ENGINEER'S STAMP		APPROVAL STAMP		DRAWN: GS DATE: 25/03/91		I.P. Constructors Ltd. Calgary, Alberta Canada				
									CHECKED: 0.44 DATE: 10/05/91		PROJECT: SASKATCHEWAN OIL & GAS CORPORATION MARSDEN UNIT NO. 1 LSD 1-30-44-26-W3M				
									APPROVED: [Signature] DATE: 13/05/91		TITLE: FWKO MECHANICAL P & ID				
									CADD REF: ACAD\SASKOIL\12751001		JOB NO: 1275 DRAWING NO: D-1275-10-01 REV: 0				
				REFERENCE DRAWINGS				REVISIONS							
				DRAWING DESCRIPTION				NO BY DATE DESCRIPTION APP'D							
				O 0.44 MAY 13/91 ISSUED FOR CONSTRUCTION											
				A GM APRIL 18/91 ISSUED FOR APPROVAL											